

PLANTING LEGEND


KEY	DESCRIPTION	QTY	SPACING	INSTALLED HEIGHT	MATURE HEIGHT
	Proposed Giant Green Arborvitae	8	5'	12'	40'-60'
	Proposed Ilex "Nellie Stevens" (Holly)	3	8'	12'	15'-25'
	Proposed ornamental grass	46	4'	2'	4'-5'
	Proposed Carpinus Caroliniana (American Hornbeam)	2	-	12'	20'-30'
	Existing Maple to remain	-	-	-	-
	Existing Maple to be removed	-	-	-	-
	Ground cover: Sedum (Humifusun)	-	-	1"	1"
	Existing Bamboo to remain	-	-	-	-

LIGHTING LEGEND

KEY	DESCRIPTION	QTY	MANUFACTURER	MODEL NO	LLF	WATTAGE	MOUNTING HEIGHT
	LIGHTING FIXTURE A	11	COOPER LIGHTING SOLUTIONS - MCGRAW-EDISON (FORMERLY EATON)	TT-C3-LED-E1-WQ-8030	1	45	8'
	LIGHTING FIXTURE B	1	COOPER LIGHTING SOLUTIONS - LUMARK (FORMERLY EATON)	PRV-C15-D-UNV-T3-BZ-HSS	1	52	15'
	LIGHTING FIXTURE C	3	COOPER LIGHTING SOLUTIONS - LUMARK (FORMERLY EATON)	AXCS3ARL-W	1	26.6	9'
	LIGHTING FIXTURE D	7	B-K LIGHTING, INC.	VS-LED-e102-NSP-12	1	4.88	8'
	LIGHTING FIXTURE G	6	GENERATION BRANDS	7000WTAGSSD1UNV830C	1	10.3	6'

STATISTICS

DESCRIPTION	SYMBOL	AVG	MAX	MIN	MAX/MIN	AVG/MIN
GROUND	+	4.4 fc	20.5 fc	0.3 fc	68.3:1	14.7:1
PROP LINE	+	0.2 fc	0.8 fc	0.0 fc	N/A	N/A

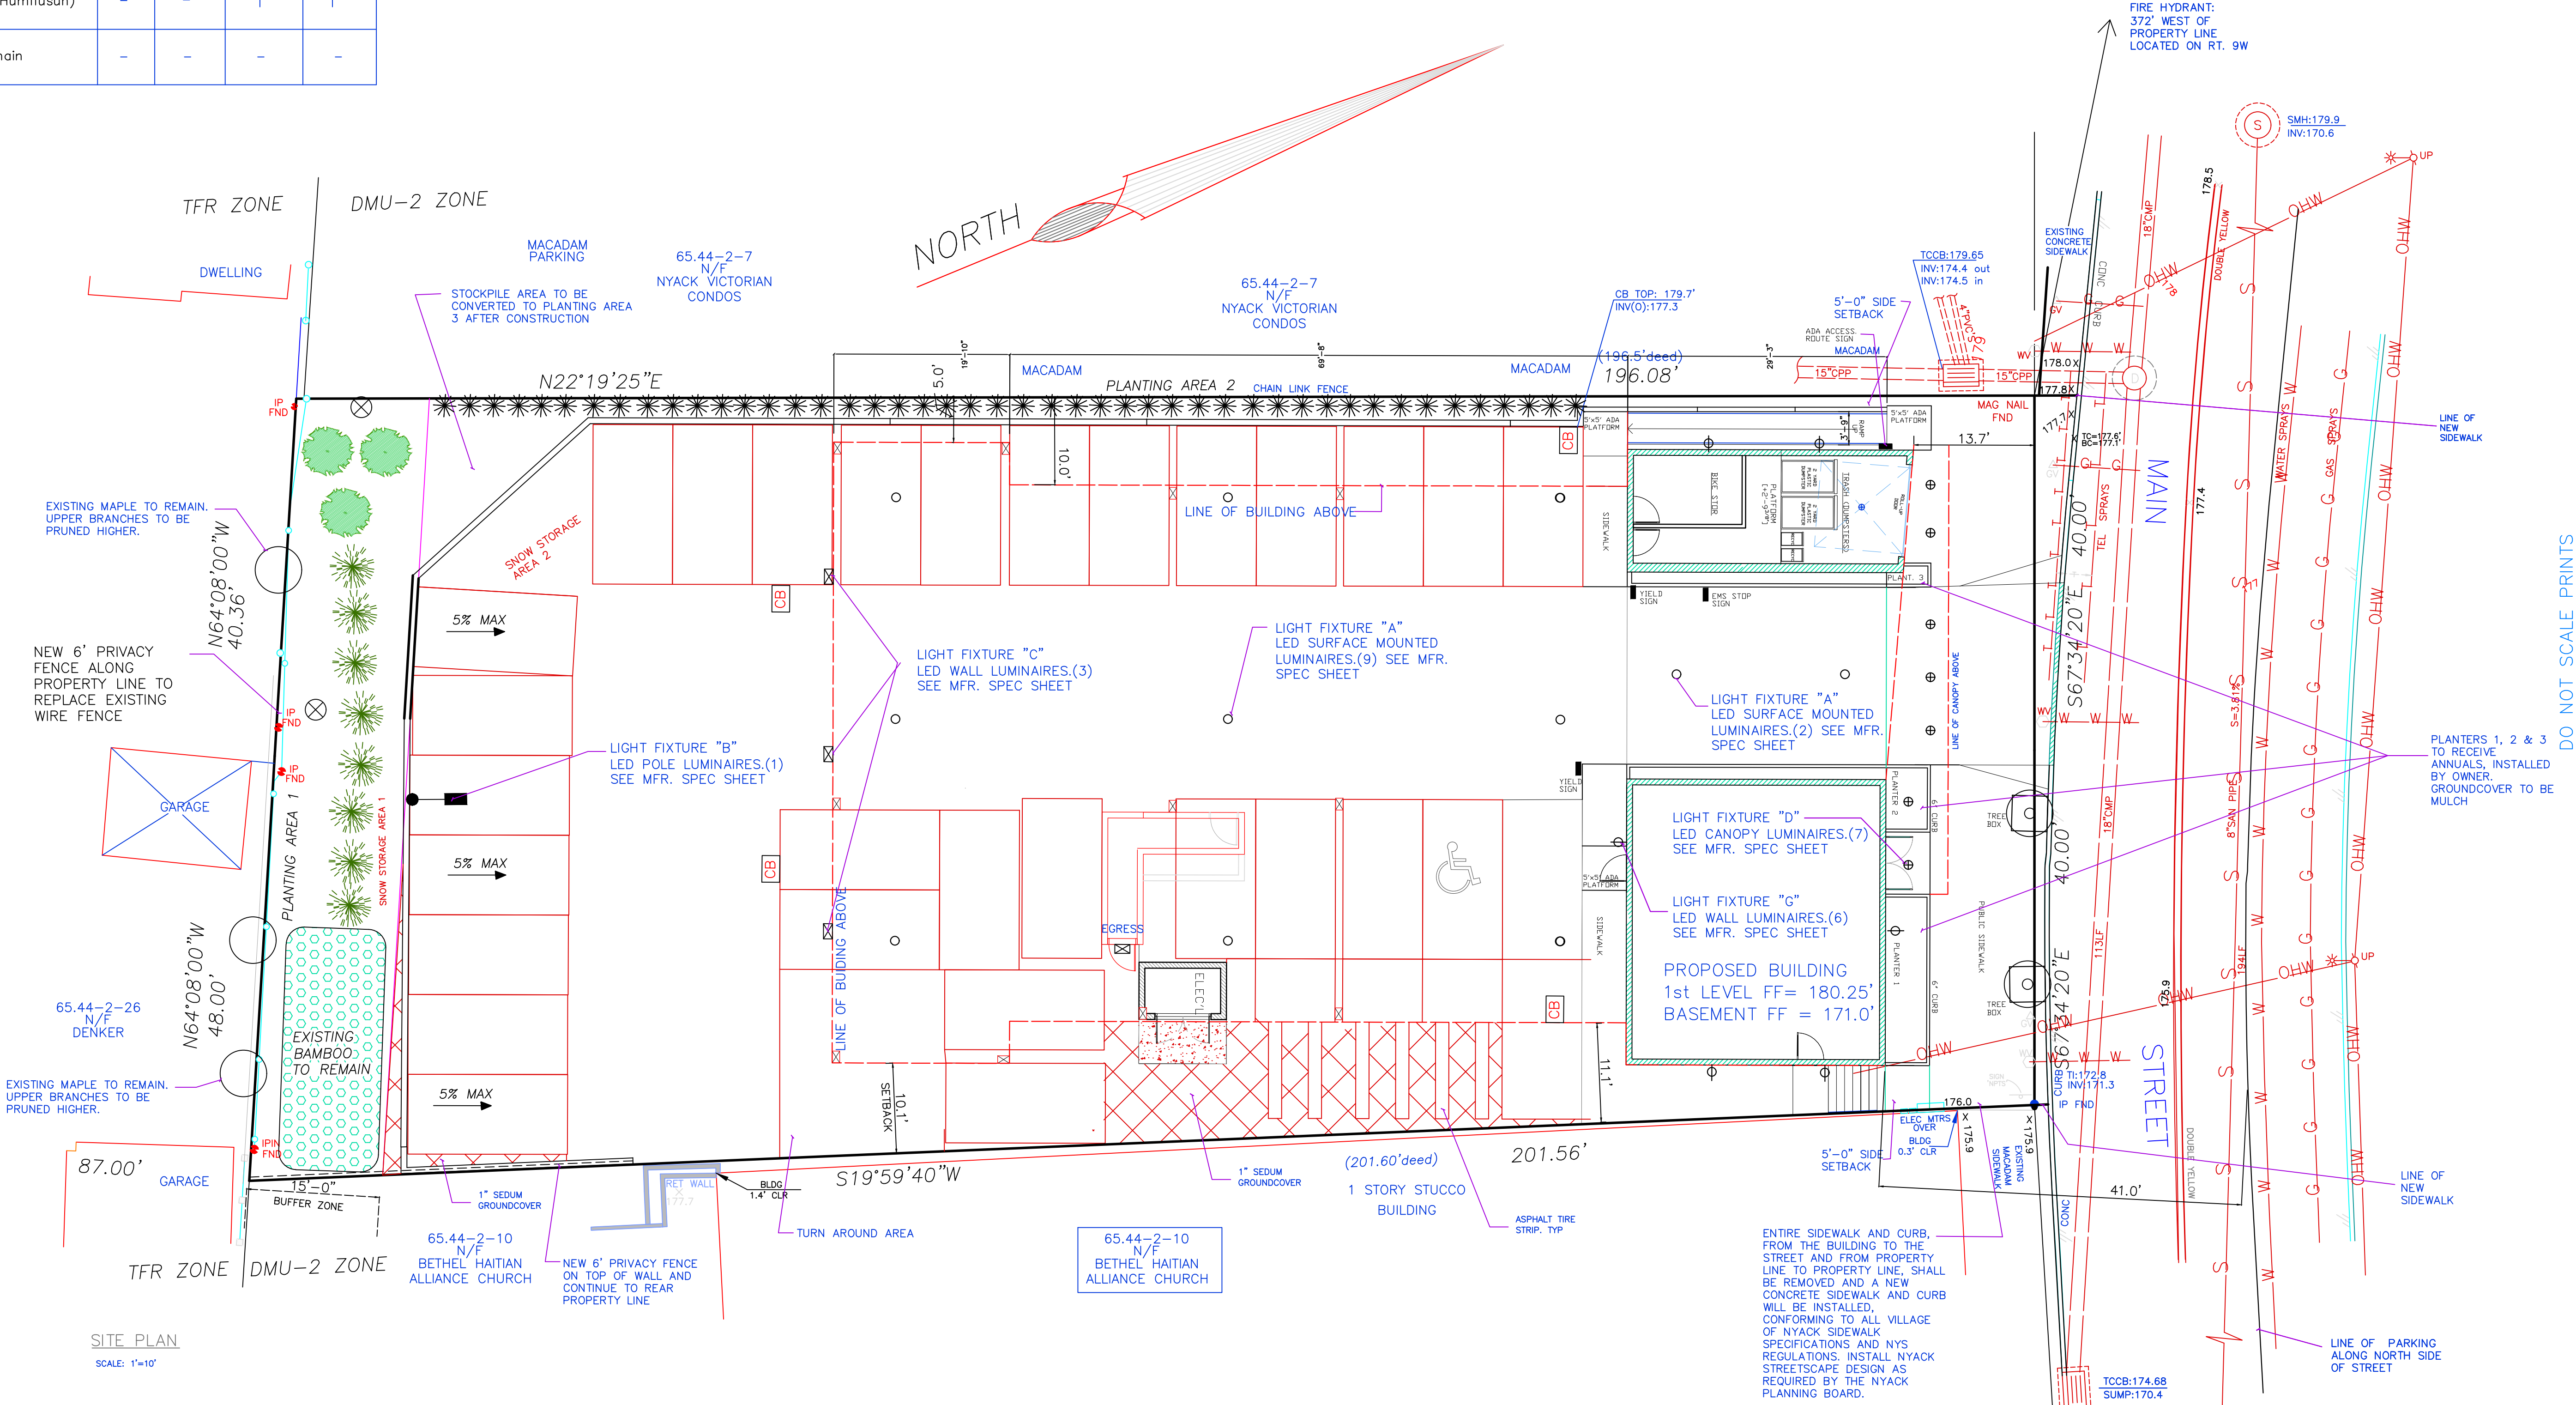

SITE PLAN
SCALE: 1"=10'

DATE:	16 APRIL 2020
	17 APRIL 2020
	14 MAY 2020

DATE:	13 MARCH 2020
	16 MARCH 2020
	17 MARCH 2020
	3 APRIL 2020
	6 APRIL 2020
	13 APRIL 2020

DATE:	9 MAY 2019
	6 JUNE 2019
	10 JUNE 2019
	11 JUNE 2019
	27 JUNE 2019
	12 MARCH 2020

SCALE:	AS NOTED
SHEET:	SP-4

DIANA PLACE	249-259 MAIN STREET NYACK, NEW YORK 10960 TAX LOT NO. 65.44-2-8 TAX LOT NO. 65.44-2-9
-------------	--

LIGHTING PLAN LANDSCAPING PLAN

BART M. RODI - ENGINEER RESIDENTIAL & COMMERCIAL 234 SOUTH GRANT AVE CONGERS, NEW YORK 10920 (845) 268-6663

NYS LIC #070545 PLANS VALID ONLY IF SEALED
