


LIGHTING LEGEND

KEY	DESCRIPTION	QTY	MANUFACTURER	MODEL NO	LLF	WATTAGE	MOUNTING HEIGHT
○	LIGHTING FIXTURE A	11	COOPER LIGHTING SOLUTIONS – MCGRAW-EDISON (FORMERLY EATON)	TT-C3-LED-E1-WQ-8030	1	45	8'
●	LIGHTING FIXTURE B	1	COOPER LIGHTING SOLUTIONS – LUMARK (FORMERLY EATON)	PRV-C15-D-UNV-T3-BZ-HSS	1	52	15'
⊠	LIGHTING FIXTURE C	3	COOPER LIGHTING SOLUTIONS – LUMARK (FORMERLY EATON)	AXCS3ARL-W	1	26.6	9'
⊕	LIGHTING FIXTURE D	7	B-K LIGHTING, INC.	VS-LED-e102-NSP-12	1	4.88	8'
⊖	LIGHTING FIXTURE G	6	GENERATION BRANDS	7000WTAGSSD1UNV830C	1	10.3	6'

STATISTICS

DESCRIPTION	SYMBOL	AVG	MAX	MIN	MAX/MIN	AVG/MIN
GROUND	+	4.4 fc	20.5 fc	0.3 fc	68.3:1	14.7:1
PROP LINE	+	0.2 fc	0.8 fc	0.0 fc	N/A	N/A

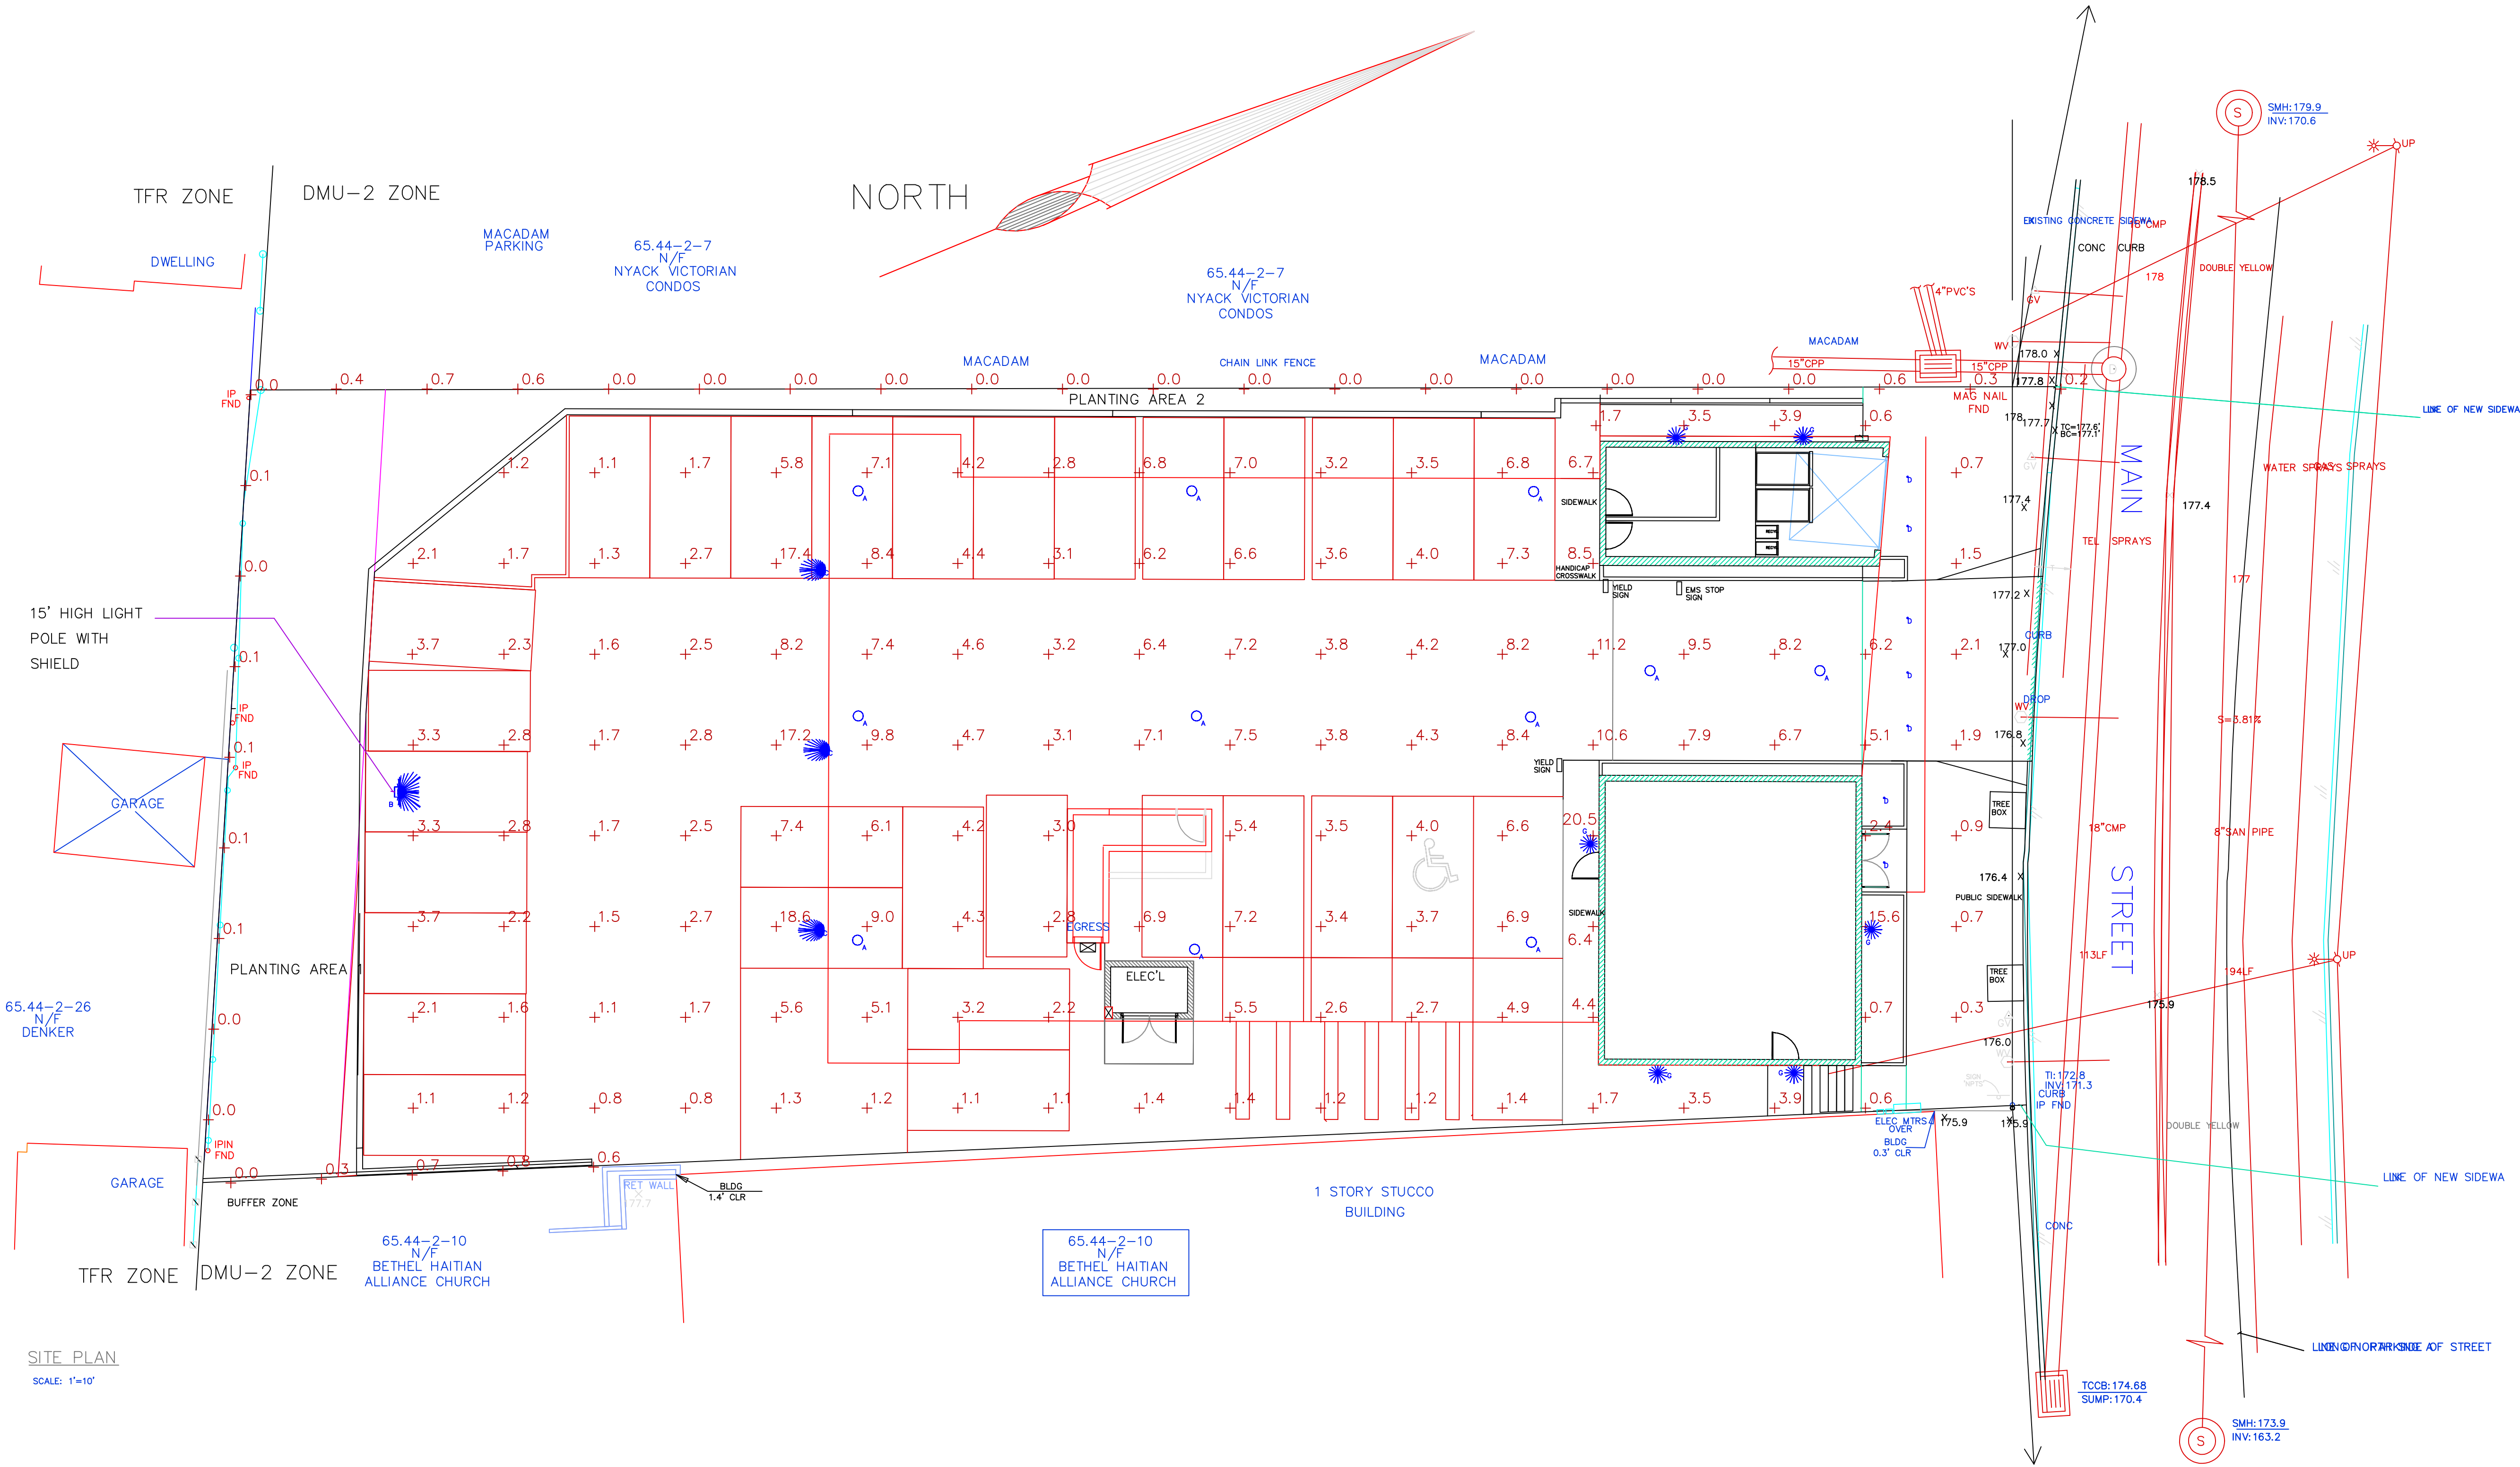

SITE PLAN
SCALE: 1"=10'

DO NOT SCALE PRINTS

DATE:
13 APRIL 2020
15 APRIL 2020
16 APRIL 2020
17 APRIL 2020
14 MAY 2020
15 MAY 2020

DATE:
18 MAY 2020

SCALE:
AS NOTED

SHEET:
SP-4A

DIANA PLAGE
249-259 MAIN STREET
NYACK, NEW YORK 10960
TAX LOT NO. 65.44-2-8
TAX LOT NO. 65.44-2-9

BART M. RODI – ENGINEER
RESIDENTIAL & COMMERCIAL
234 SOUTH GRANT AVE
CONGERS, NEW YORK 10920
(845) 268-6663

INVS LIC #070545
PLANS VALID ONLY IF SEALED