


[illegible]

Equipment & Seating Plan

-

First Floor

A2.0

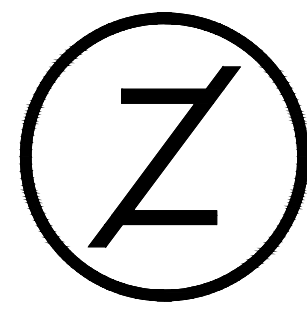


Z E L T A
DESIGN

P: 973-933-6636 E: hello@zeltadesign.com
45 Sussex Avenue
Newark, New Jersey 07103

Revisions

No.	Description	Date

DOB Approval Stamp:

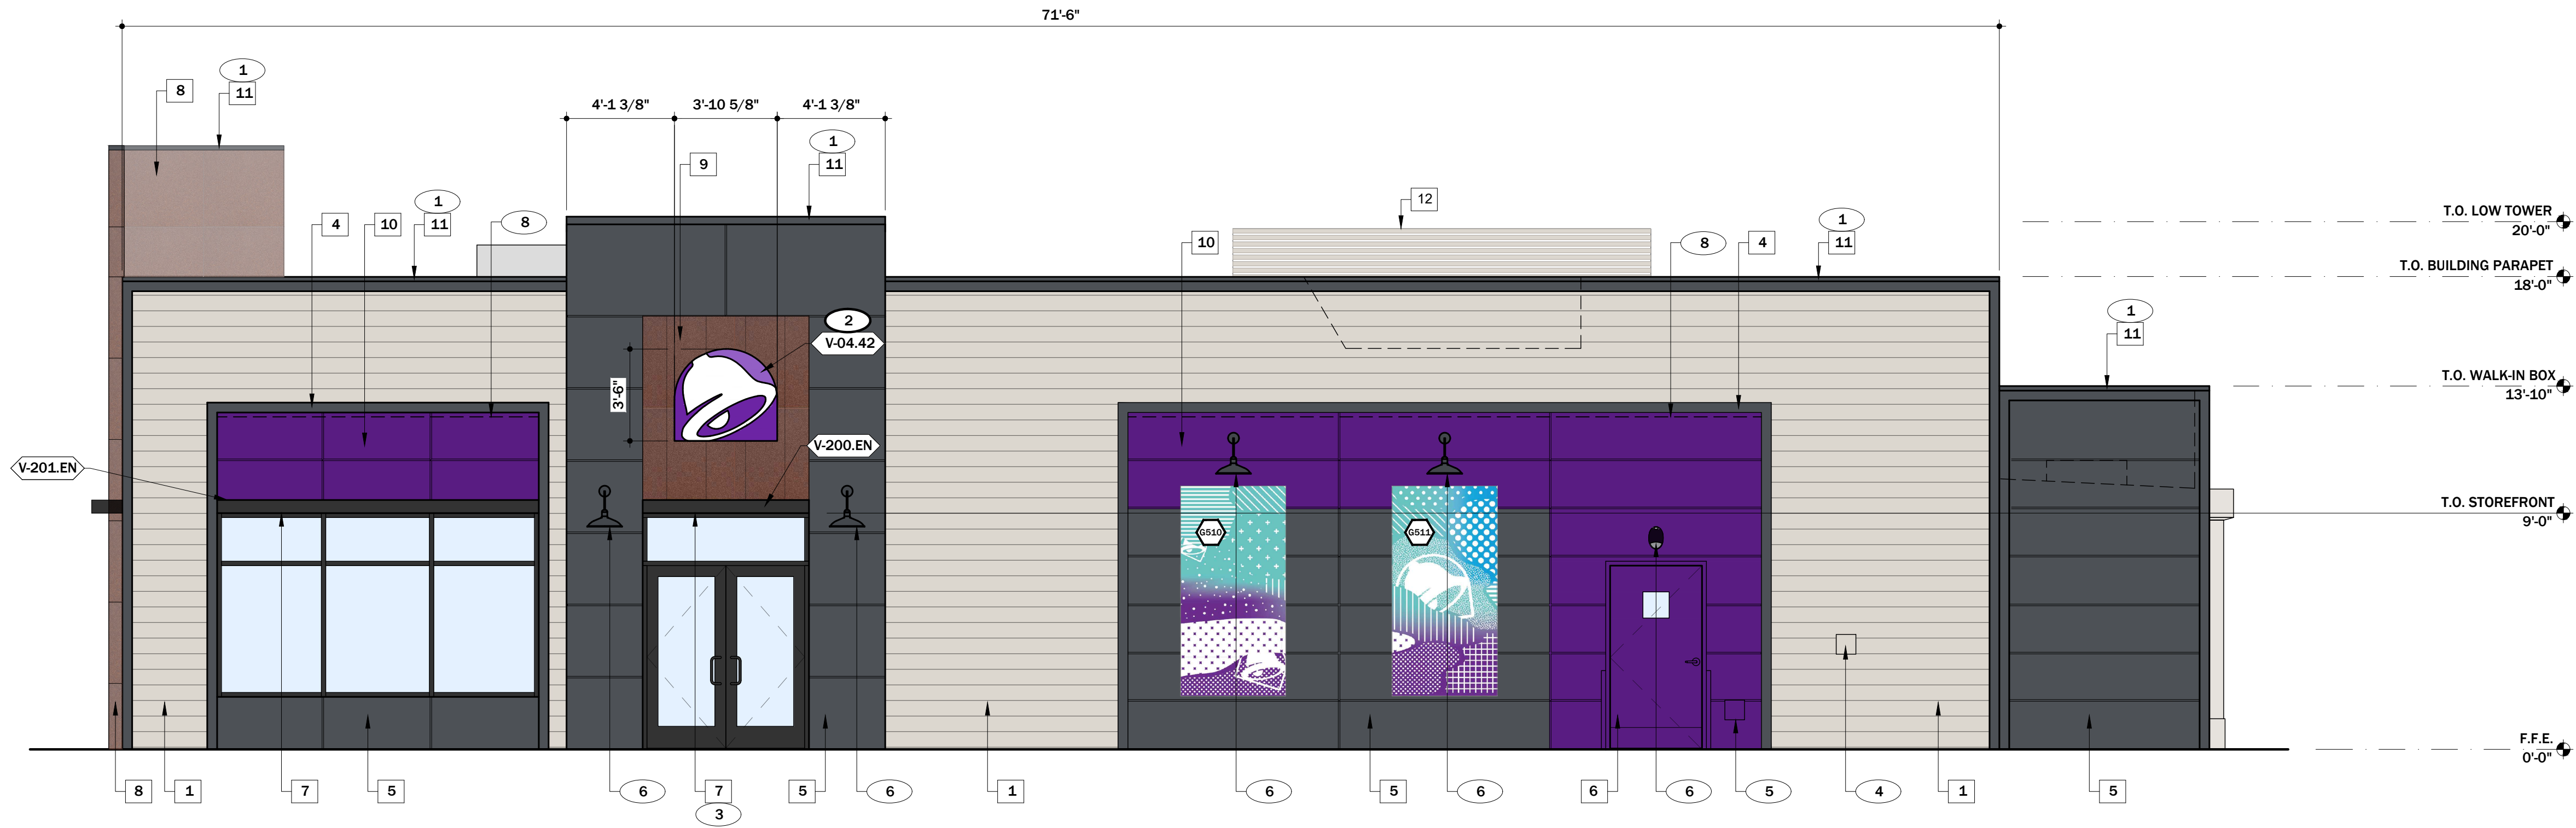

EAST ELEVATION 1/4" = 1'-0" A

TYPE MARK	QTY	ITEM DESCRIPTION	LOC
TOWER			
V-04.42	2	42" SWINGING BELL PURPLE LOGO FACE LIT	A4.1
V-09.14W	2	14" WHITE CHANNEL LETTERS VERTICAL	A4.1
SIDE ENTRY			
V-04.42	2	42" SWINGING BELL PURPLE LOGO FACE LIT	A4.1
V-200.EN	1	SIDE ENTRY AWNING 6'-4" X 6'-3" BLACK	A4.0
DRIVE THRU			
V-101.DT	1	DT AWNING (OVER DT) 9' 0" X 4' 0" BLACK	A4.1
EYEBROW AWNINGS			
V-202.EN	1	FRONT EYEBROW (WINDOW) 16' 7" X 6" H X 1' 4" D BLACK	A4.1
V-203.EN	1	DT EYEBROW (WINDOW) 7' 8" L X 6" H X 1' 4" D BLACK	A4.1
V-201.EN	1	SIDE ENTRY EYEBROW (WINDOW) 12'-3" L X 6" H X 1' 4" D BLACK	A4.1


SIGNAGE F

SYMBOL	ITEM/MATERIAL	MANUFACTURER	MATERIAL SPEC	COLOR
1	SIDING	JAMES HARDIE	ARTISAN V-GROOVE 144"L X 8.25"W; 7" EXPOSURE COMES PRIMED FOR PAINT	WORLDLY GRAY (SW7043), SEMI-GLOSS
2	SCUPPERS	-	-	WORLDLY GRAY (SW7043), SEMI-GLOSS
3	DOWN SPOUTS	-	-	WORLDLY GRAY (SW7043), SEMI-GLOSS
4	HARDIE TRIM	JAMES HARDIE	HARDIE TRIM 5/4 SMOOTH 1"x5.5"	CYBERSPACE (SW7076), SEMI-GLOSS
5	HARDIE REVEAL PANEL	JAMES HARDIE	REVEAL PANEL SYSTEM	CYBERSPACE (SW7076), SEMI-GLOSS
6	HOLLOW METAL DOOR	-	-	SW PURPLE TB2603C, SEMI-GLOSS
7	AWNINGS	SIGNAGE VENDOR	-	BLACK BY THE SIGN VENDOR
8	CORNER TOWER	WESTERN STATE	T-GROOVE 24 GA PAINTED 18" PANEL	WEATHERED RUSTIC
9	RECESS OF SIDE ENTRY PORTAL	WESTERN STATE	T-GROOVE 24 GA PAINTED 18" PANEL	WEATHERED RUSTIC
10	HARDIE REVEAL PANEL	JAMES HARDIE	REVEAL PANEL SYSTEM	SW PURPLE TB2603C, SEMI-GLOSS
11	METAL PARAPET CAP	-	24GA GALVANIZED	CYBERSPACE (SW7076) KYNAR 500 COATING
12	HVAC SCREENING			

EXTERIOR FINISH SCHEDULE B

- 1 METAL PARAPET CAP.
- 2 BUILDING SIGN BY VENDOR. REQUIRES ELECTRICAL, SEE ELECTRICAL PLANS.
- 3 METAL CANOPIES BY VENDOR. REQUIRES ELECTRICAL, SEE ELECTRICAL PLANS.
- 4 CO2 FILLER VALVE & COVER.
- 5 HOSE BIB BOX AT 18" A.F.F.
- 6 EXTERIOR LIGHT FIXTURE. COORDINATE WITH ELECTRICAL DRAWINGS.
- 7 PURPLE LIGHT WALL WASHER, PROVIDED BY SIGNAGE VENDOR.

KEY NOTES G

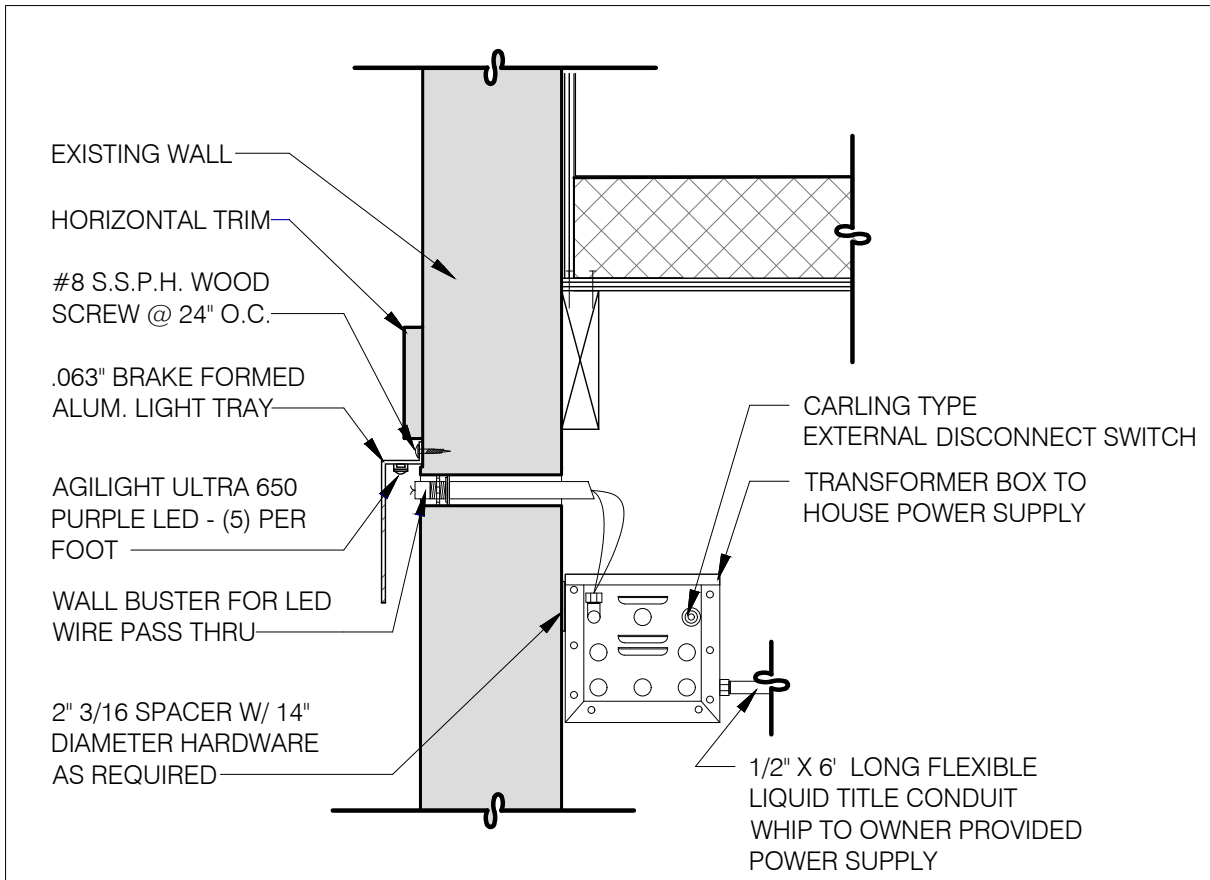

LED WALL WASHER DETAIL N.T.S. E

- SEALERS (REFER TO SPECS)
- A. SEALANT AT ALL WALL AND ROOF PENETRATIONS.
 - B. SEALANT AT ALL WINDOW AND DOOR FRAMES AND JAMB. DO NOT SEAL SILL @ WINDOWS.
 - C. APPLY NEOPRENE GASKET (CONT.) BETWEEN BUILDING AND CANOPY.

- CRITICAL DIMENSIONS
- A. REQUIRED CLEAR OPENING WIDTH TO ENSURE COORDINATION WITH STANDARD SIGNAGE/BUILDING ELEMENTS DIMENSIONS.

NOTE: NO EXTERIOR SIGNS ARE WITHIN THE SCOPE OF WORK COVERED BY THE BUILDING PERMIT APPLICATION. THE GENERAL CONTRACTOR SHALL BE RESPONSIBLE FOR COORDINATING THE INSTALLATION OF ALL EXTERIOR SIGNS AND INSTALLATION OF REQUIRED BLOCKING AND ELECTRICAL CONNECTIONS FOR FINAL APPROVED SIGNS.

PAINTING
APPLICATOR MUST DO THEIR DUE DILIGENCE WITH PREPARATION.
PRIMER: 1 COAT SW A24W8300
FINISH: 2 COATS SW A82-100 SERIES, MATCH COLORS FROM MATERIAL SCHEDULE.
A-100 EXTERIOR LATEX SATIN.

GENERAL NOTES D

PAINT NOTES C



Taco Bell
Endeavor 2.0

27 NY-59
Nyack, New York 10960

Exterior Elevation

Project No. Z224-21

Date: 09/14/2021

Drawn By: SM

Scale: As Noted

NY License No.
042821

DOB NOW Job No:

A4.0




NOTE: REFERENCE SHEET A4.0 FOR COLOR LEGEND

WEST ELEVATION 1/4" = 1'-0" A



NOTE: REFERENCE SHEET A4.0 FOR COLOR LEGEND

SOUTH ELEVATION 1/4" = 1'-0" C

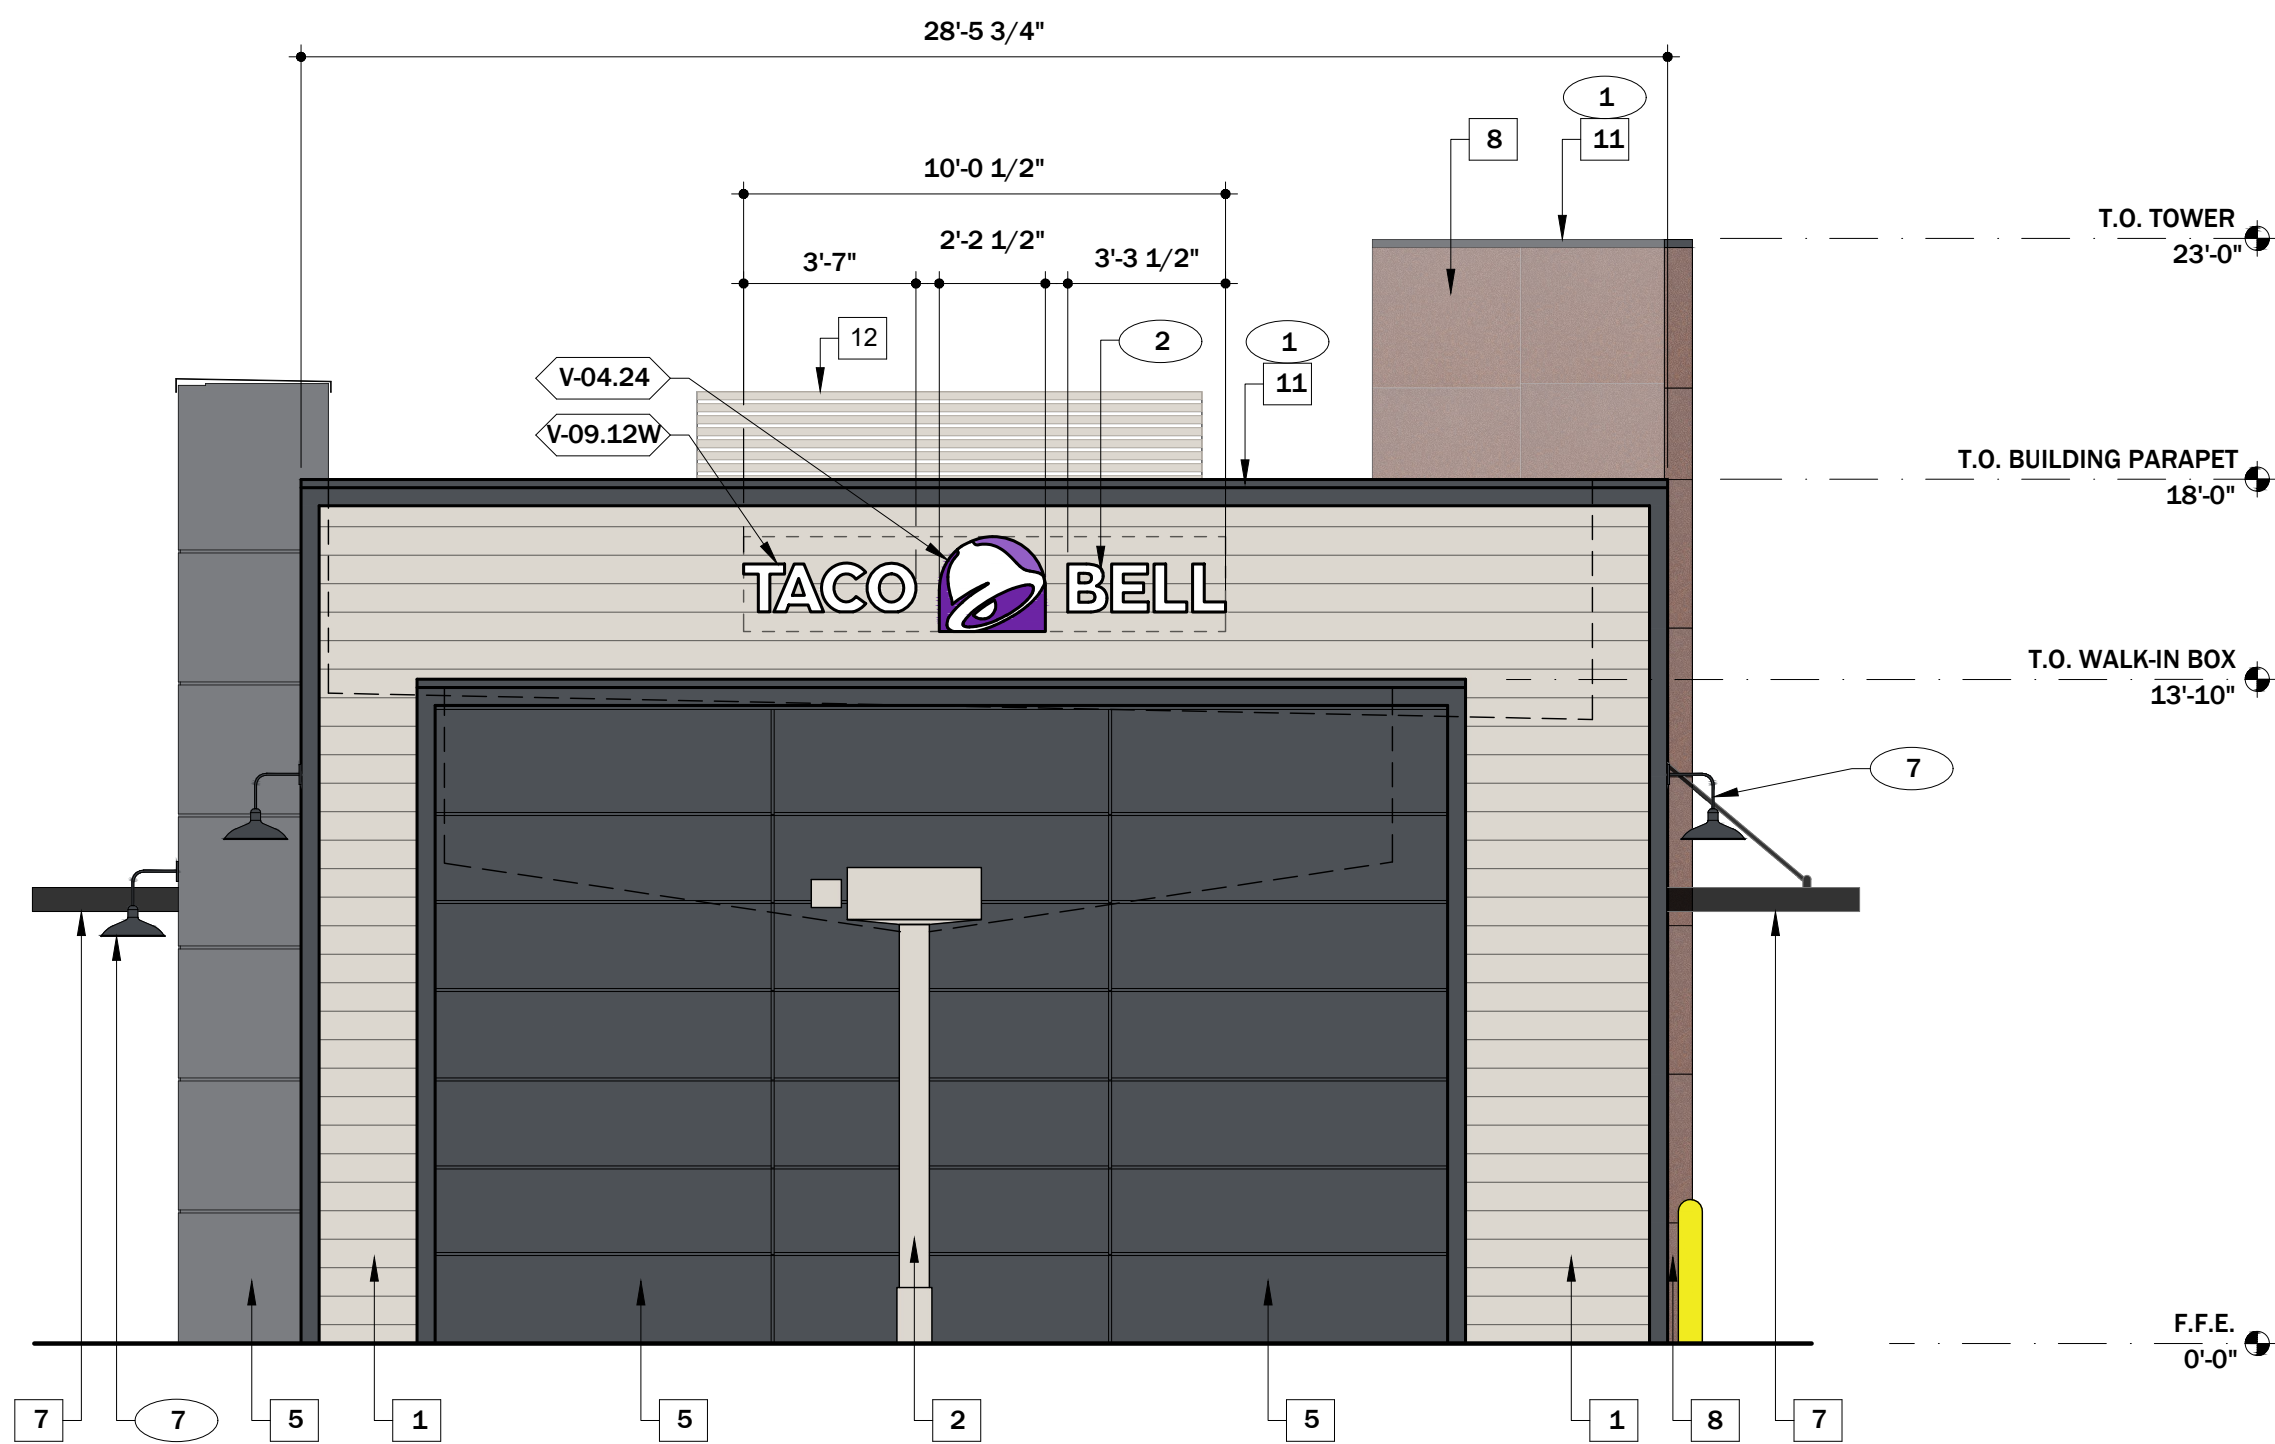


NOTE: REFERENCE SHEET A4.0 FOR COLOR LEGEND

NORTH ELEVATION 1/4" = 1'-0" B

- 1 METAL PARAPET CAP
- 2 BUILDING SIGN BY VENDOR. REQUIRES ELECTRICAL. SEE ELECTRICAL PLANS.
- 3 DRIVE THRU WINDOW.
- 4 METAL CANOPIES BY VENDOR. REQUIRES ELECTRICAL.
- 5 ASSUME D/T LANE SURFACE IS 6" BELOW THE FINISH FLOOR. REFER TO GRADING & SITE PLAN.
- 6 CONCRETE CURB.
- 7 EXTERIOR LIGHT FIXTURE. COORDINATE WITH ELECTRICAL DRAWINGS.
- 8 PURPLE LIGHT WALL WASHER, PROVIDED BY SIGNAGE VENDOR.

NOT USED E

KEY NOTES D

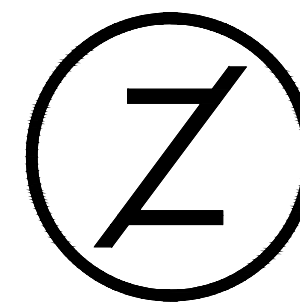

ZELTA
DESIGN

P: 973-933-6636 E: hello@zeltadesign.com
45 Sussex Avenue
Newark, New Jersey 07103

Revisions

No.	Description	Date

DOB Approval Stamp:



Taco Bell
Endeavor 2.0

27 NY-59
Nyack, New York 10960

Exterior Elevations
-
Continued

Project No. Z224-21

Date: 09/14/2021

Drawn By: SM

Scale: As Noted

NY License No.
042821

DOB NOW Job No:

A4.1